
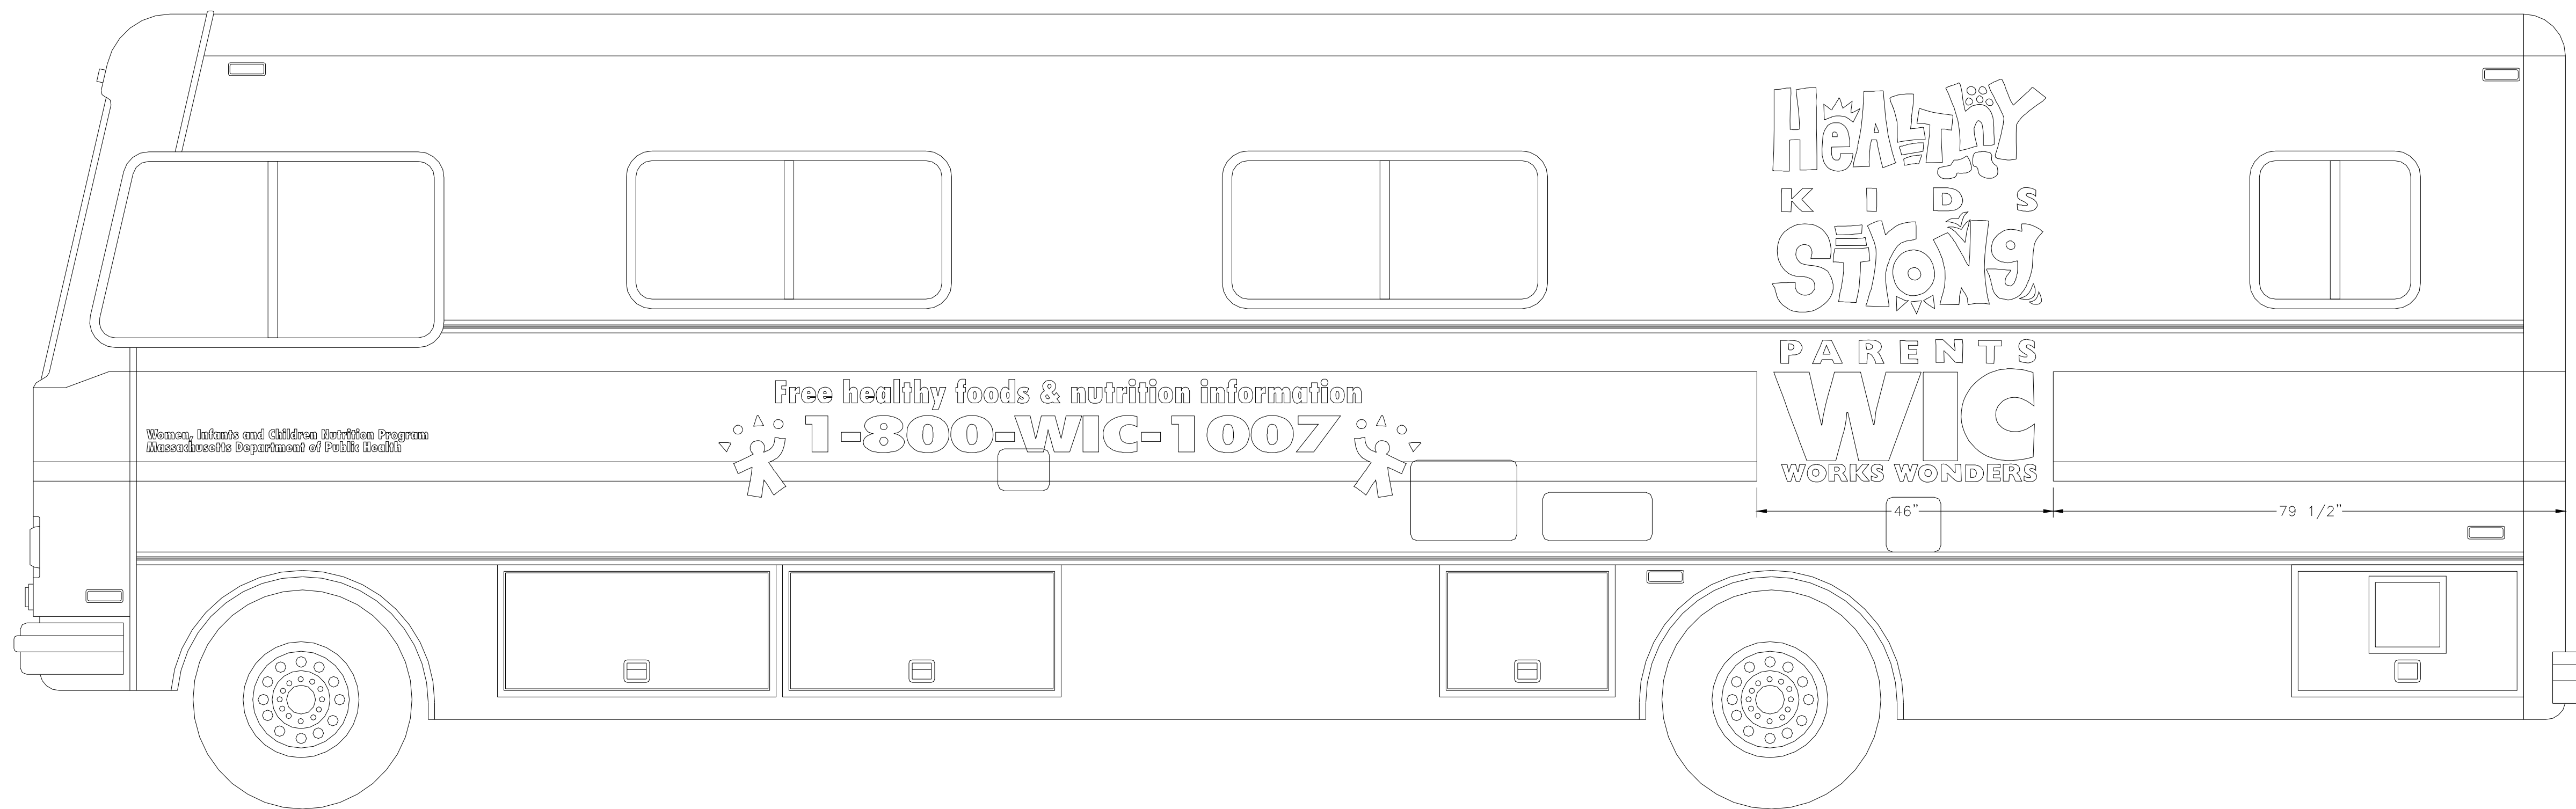
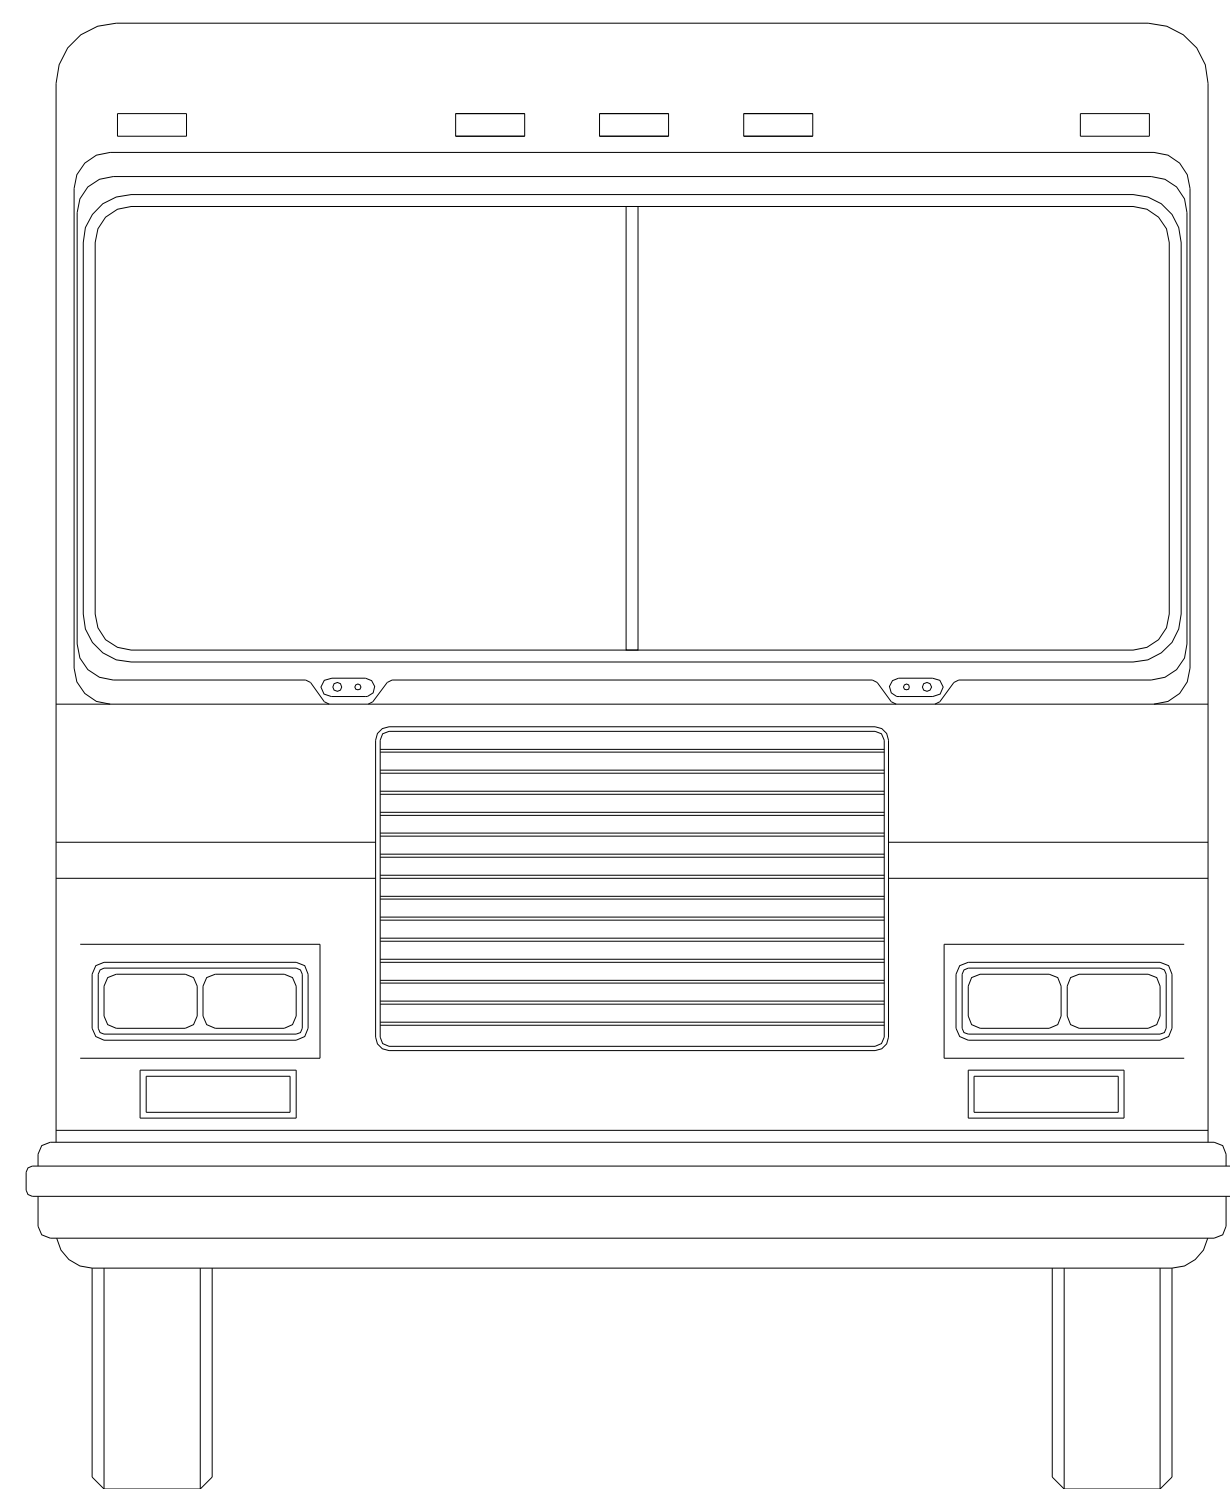


6"
AQUA STRIPE
14"
ROYAL PURPLE
3"

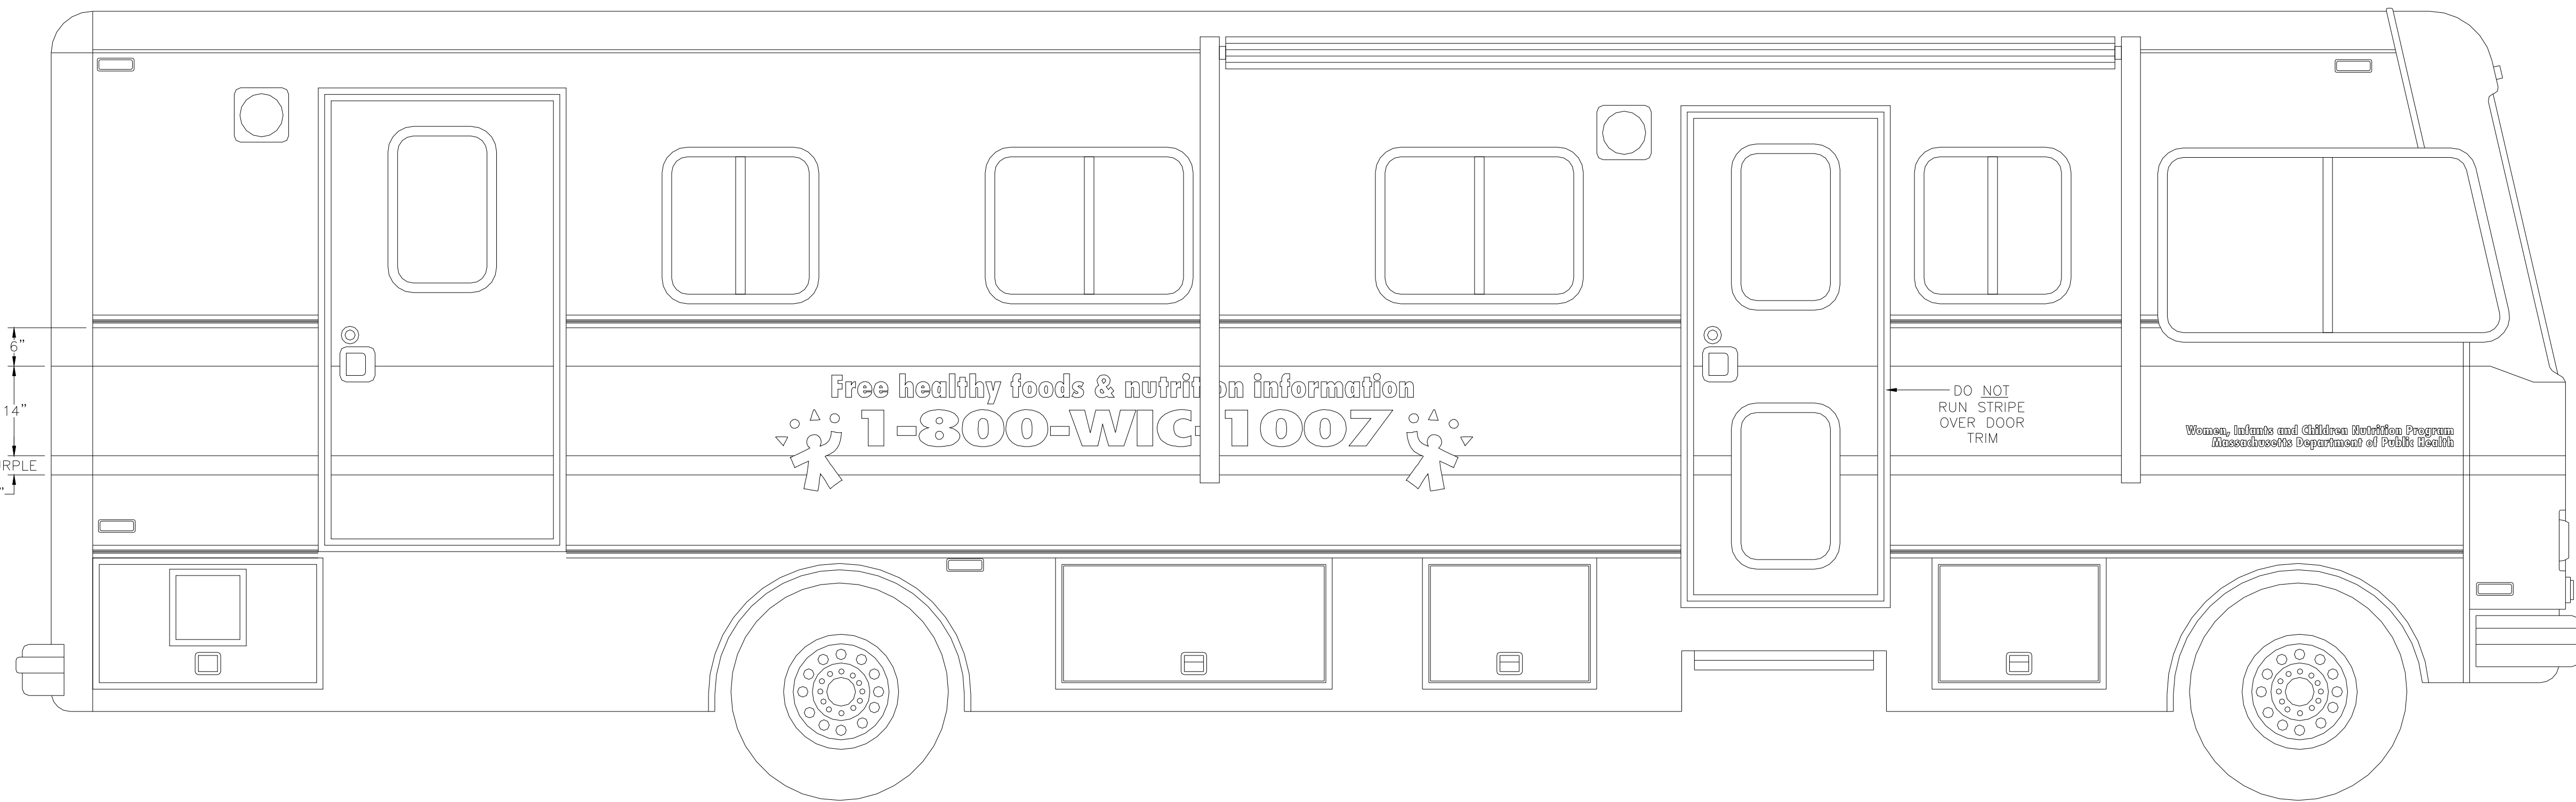

PC SPECIALIZED COMMERCIAL COACHES

CUSTOMER	MASSACHUSETTS DEPARTMENT OF PUBLIC HEALTH		
DATE	20 DEC. 95		
WHEELBASE	228"		
TRANSMISSION	4 SPD. AUTO	CHASSIS	CHEVROLET
MODEL NO.	33S144 & 33S145	ENGINE	454 CID. GAS
COMPUTER NO.	144EX	SCALE	3/4"=1'-0"
PLAN TYPE	EXTERIOR ELEVATIONS	DRAWN BY	JM

LC
CAP-SERVICES
A Division of Lake City Awings & Signs, Inc.
10203 S.R. 13, Syracuse, In. 46567
Ph: 574-528-6061 Fax: 574-528-6063
Toll Free: 1-866-269-4447

NOTICE:
THIS DRAWING AND THE DATA THEREON SHALL NOT BE DUPLICATED, USED OR DISCLOSED TO OTHERS FOR PROCUREMENT OR MANUFACTURING PURPOSES, EXCEPT AS OTHERWISE AUTHORIZED BY CONTRACT, WITHOUT THE WRITTEN PERMISSION OF PEI SPECIALIZED COMMERCIAL COACHES.