
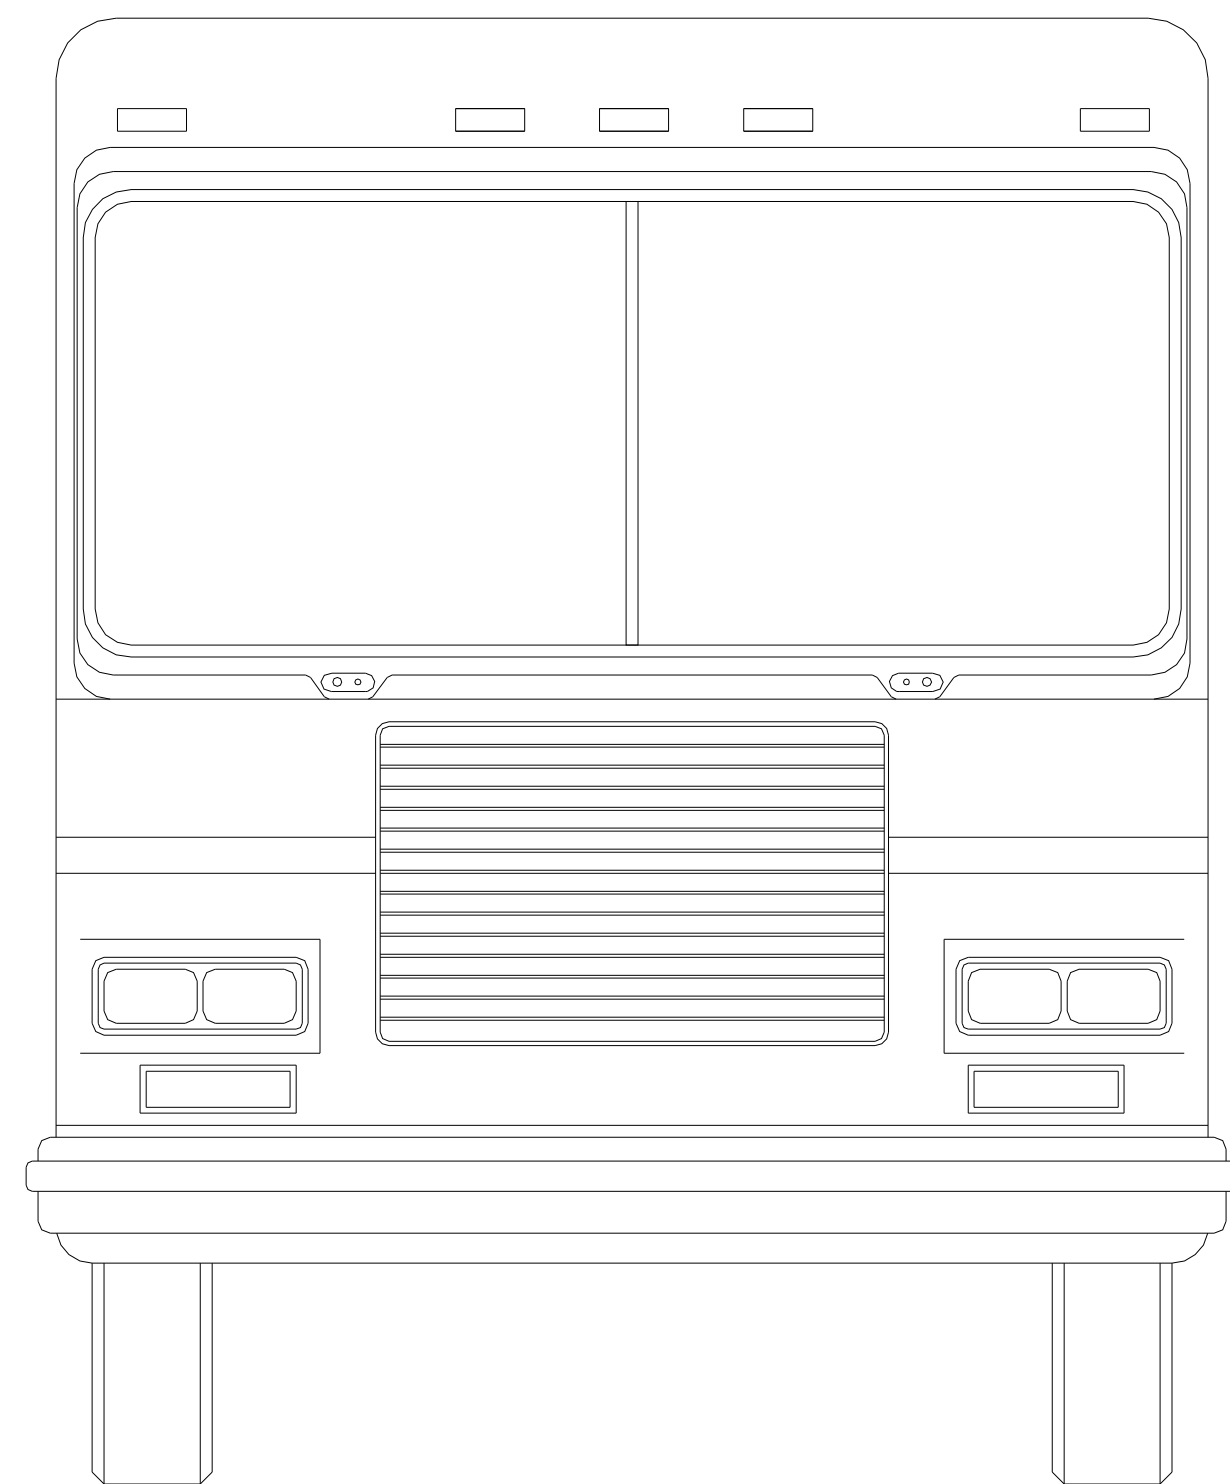


6"  
AQUA STRIPE  
14"  
ROYAL PURPLE  
3"

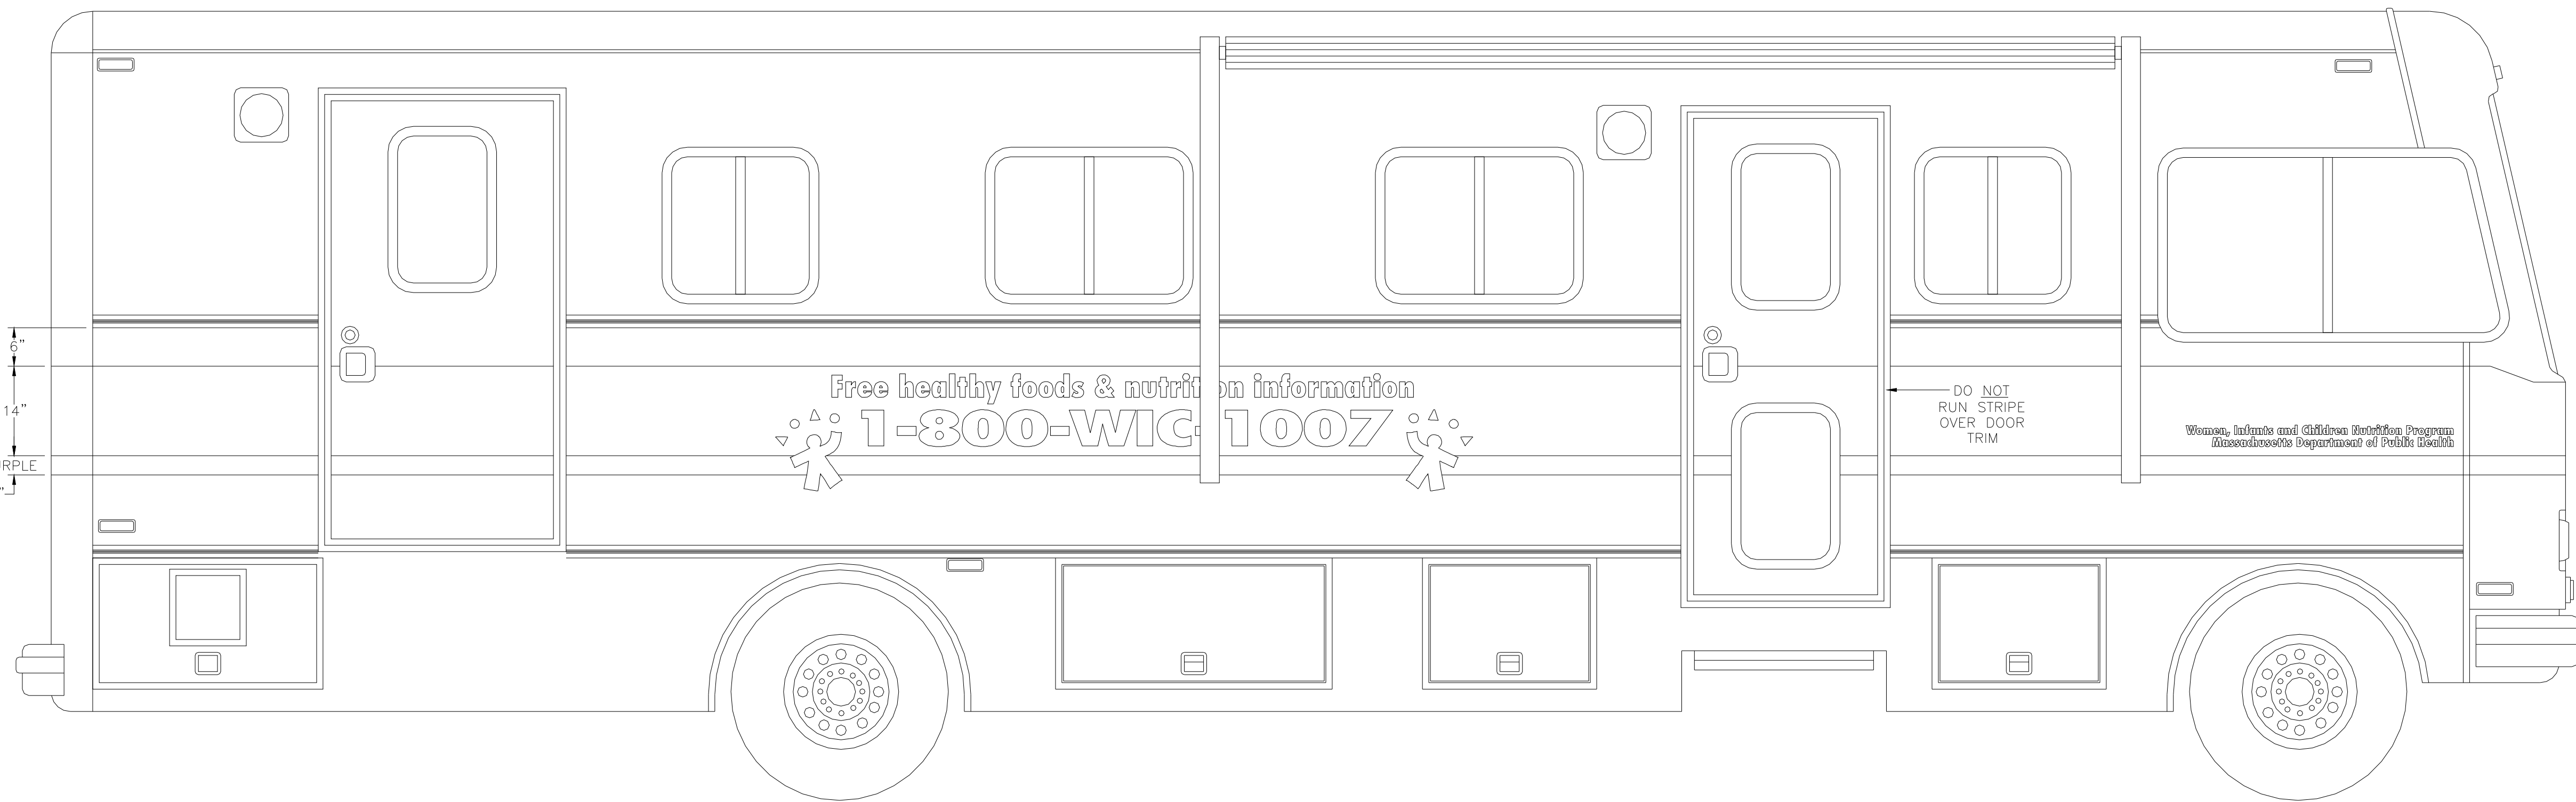

**PEI SPECIALIZED COMMERCIAL COACHES**

CUSTOMER	MASSACHUSETTS DEPARTMENT OF PUBLIC HEALTH		
DATE	20 DEC. 95		
WHEELBASE	228"		
TRANSMISSION	4 SPD. AUTO	CHASSIS	CHEVROLET
MODEL NO.	33S144 & 33S145	ENGINE	454 CID. GAS
COMPUTER NO.	144EX	SCALE	3/4"=1'-0"
PLAN TYPE	EXTERIOR ELEVATIONS	DRAWN BY	JM

**LC**  
**CAP-SERVICES**  
A Division of Lake City Awings & Signs, Inc.  
10203 S.R. 13, Syracuse, In. 46567  
Ph: 574-528-6061 Fax: 574-528-6063  
Toll Free: 1-866-269-4447

NOTICE:  
THIS DRAWING AND THE DATA THEREON SHALL NOT BE DUPLICATED, USED OR DISCLOSED TO OTHERS FOR PROCUREMENT OR MANUFACTURING PURPOSES, EXCEPT AS OTHERWISE AUTHORIZED BY CONTRACT, WITHOUT THE WRITTEN PERMISSION OF PEI SPECIALIZED COMMERCIAL COACHES.